


Developer's Name	MERITAGE HOMES		
Developer's Address	2722 W. BITTERS RD. STE. 200		
City	SAN ANTONIO	State	TEXAS
Zip	78248		
Phone #	360.00.154.000	Fax #	360.00.154.000
SAWS Block Map #	134688, 134689, 134690	Total EDU's	430
Total Linear Footage of Pipe	1,005.95 L.F. OF 8" SDR26 GRAVITY SEWER PLAT NO.	Total Acreage	N/A
Number of Lots	N/A	SAWS Job No.	20-1595

LEGEND

PROPERTY LINE	---
PROPOSED EDGE OF PAVEMENT	---
EXISTING EDGE OF PAVEMENT	---
EXISTING MAJOR CONTOUR	-1234-
EXISTING MINOR CONTOUR	-1234-
EXISTING WATER LINE	EX. 24"
ABANDONED WATERLINE	EX. 12"
EXISTING UNDERGROUND ELECTRIC	EX. OHE
EXISTING UNDERGROUND GAS LINE	EX. 4"
PROPOSED WATER LINE	W
PROPOSED DUAL DIPS HDPE FORCE MAIN (200 PSI)	6" DUAL DIPS HDPE FORCE MAIN (200 PSI)
EXISTING FIRE HYDRANT	⊕
PROPOSED FIRE HYDRANT	⊕
EXISTING POWER POLE	⊕
EXISTING METAL BEAM GAIRD FENCE	---
EXISTING ROAD PAVEMENT	---
EXISTING CONCRETE PAVEMENT	---
CUT & REPLACE PAVEMENT	---
EXISTING WATER VALVE	⊕
EXISTING TELEPHONE PEDESTAL	⊕
EXISTING WATER METER	⊕

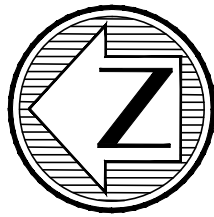


SCALE: 1"=50'

AS BUILT/PLAN OF RECORD
APRIL 30, 2024



NOTE: I HEREBY CERTIFY THAT THIS "PLAN OF RECORD" IS TRUE AND CORRECT TO THE BEST OF MY KNOWLEDGE AND PREPARED UNDER MY SUPERVISION.

NOTE: INFORMATION FOR THIS "PLAN OF RECORD" WAS PROVIDED TO CUDE ENGINEERS BY THE CONTRACTOR.

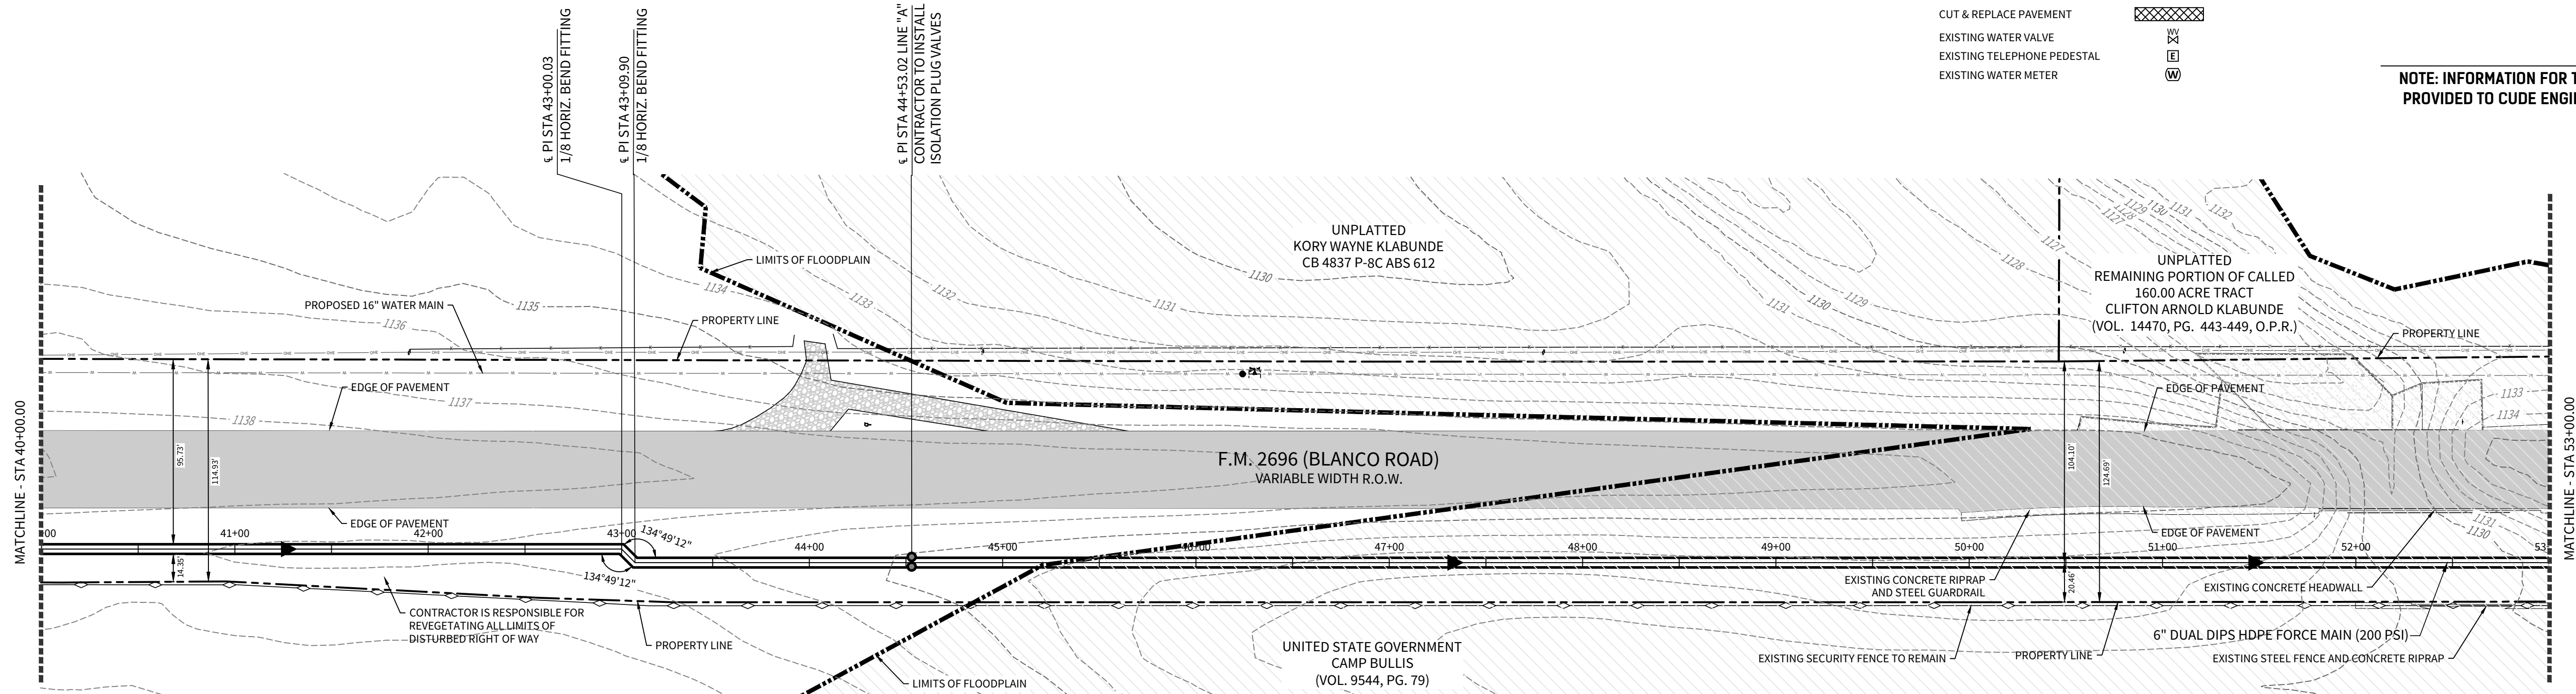

LINE 'A'
STA. 40+00.00 TO STA. 53+00.00

HORIZONTAL SCALE: 1" = 50'
VERTICAL SCALE: 1" = 5'

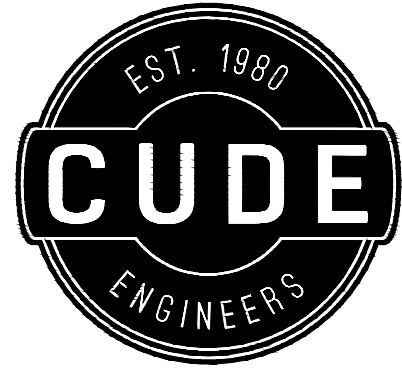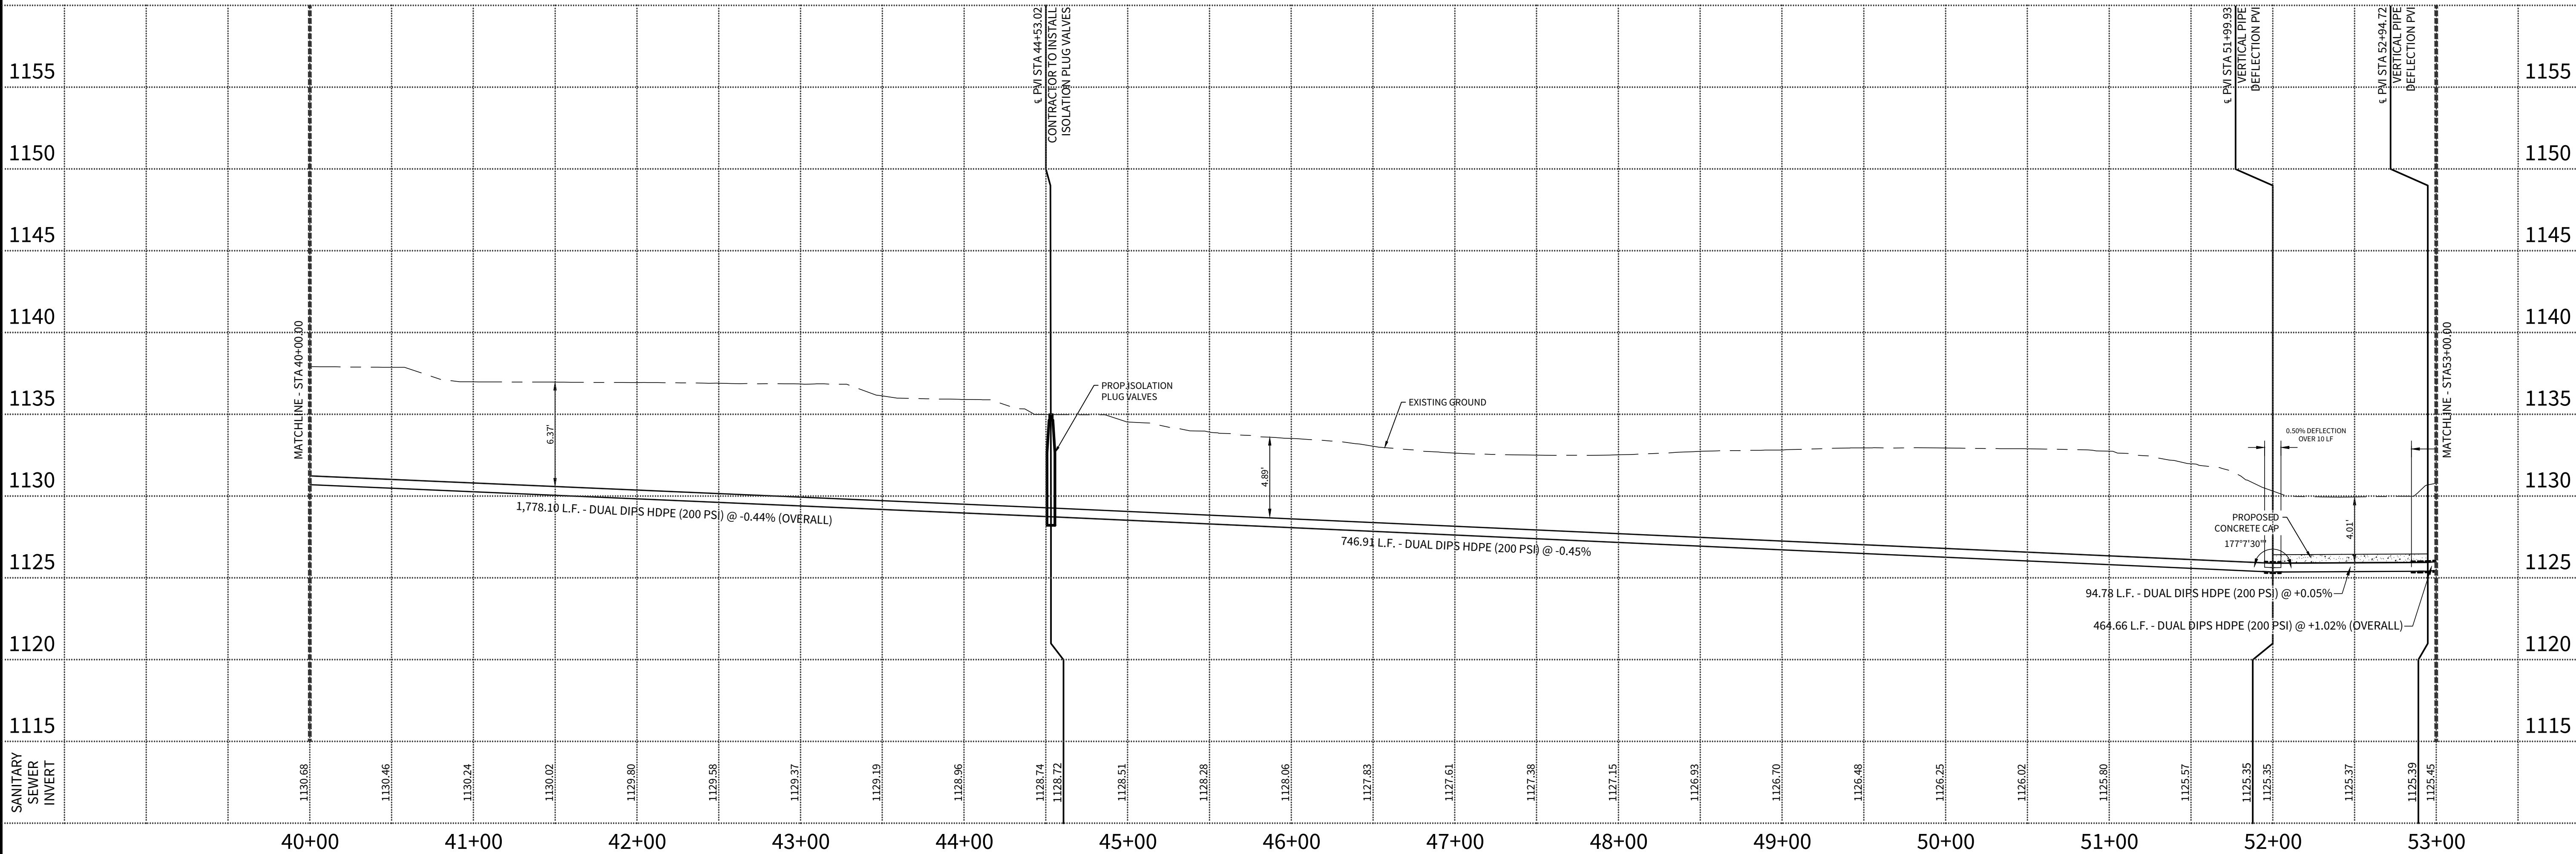

4122 Pond Hill Road, Suite 101
San Antonio, Texas 78231
P:(210) 681.2951 F:(210) 523.7112

SPECHT ROAD SUBDIVISION
OFFSITE SEWER IMPROVEMENTS
DUAL 6" FORCE MAIN & LIFT STATION

SANITARY SEWER PLAN AND PROFILE LINE 'A' - STA 40+00-53+00

DATE

04/29/2024

PROJECT NO.

03473.002

DRAWN BY

CLM

CHECKED BY

DDC

REVISIONS

- 1.
- 2.
- 3.
- 4.
- 5.
- 6.
- 7.
- 8.
- 9.

CUDE ENGINEERS

TBPE No. 455

TBPLS No. 10048500

PLAT NO.

N/A

SAWS JOB NO.

20-1595

C7

