
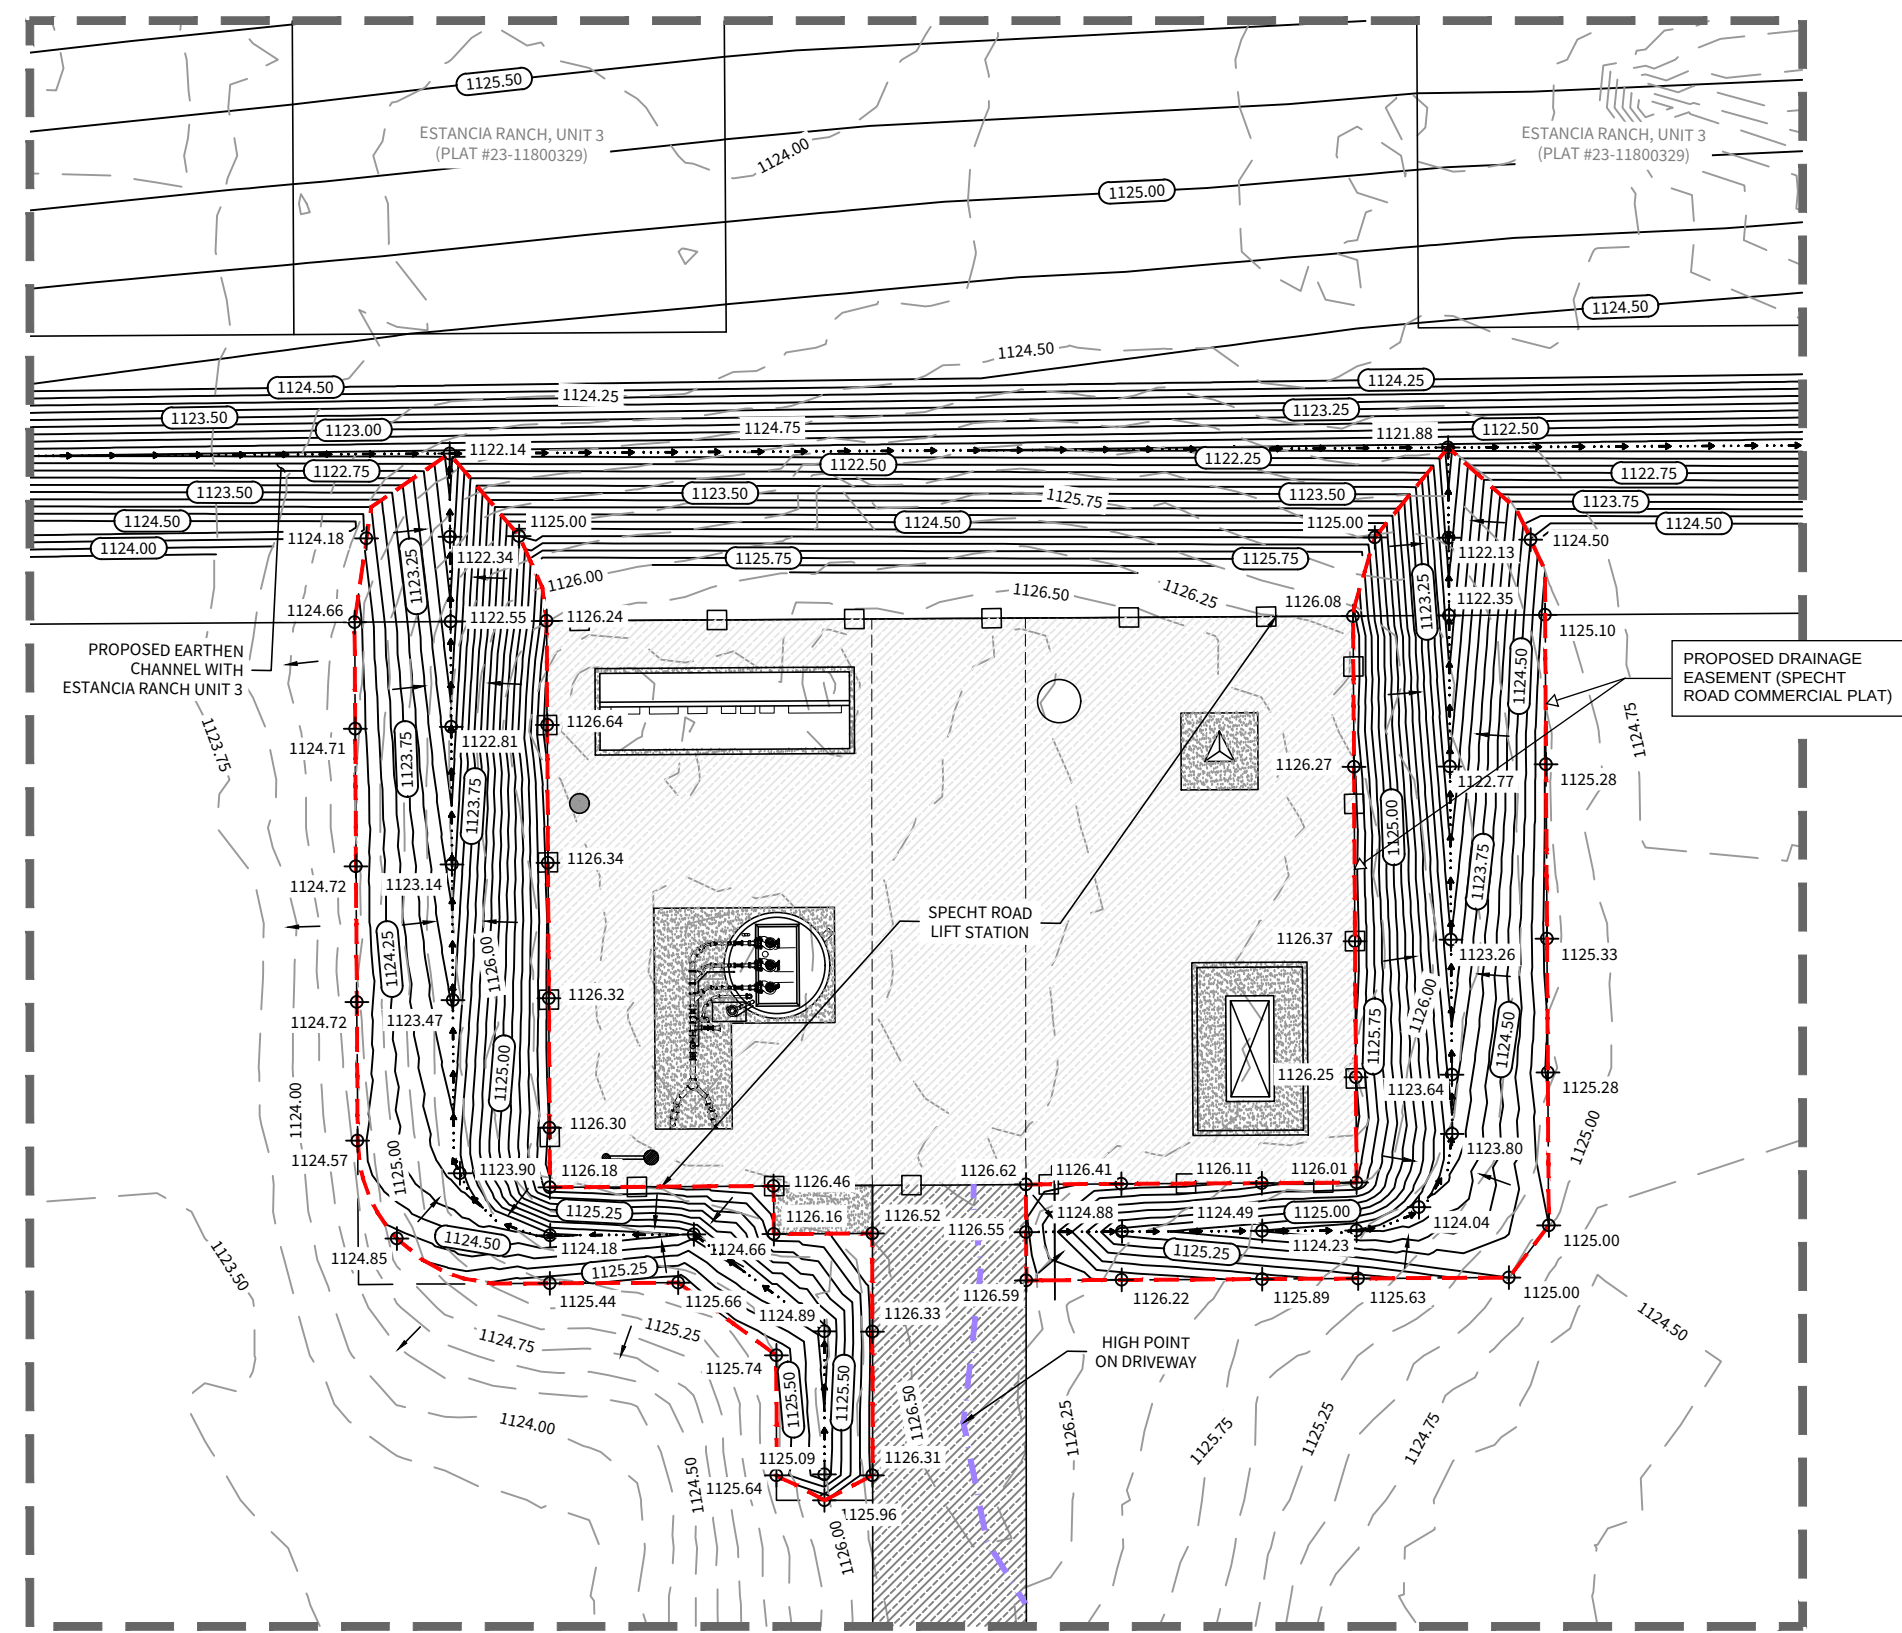



LEGEND

FLOW LINE


GRADING LIMITS

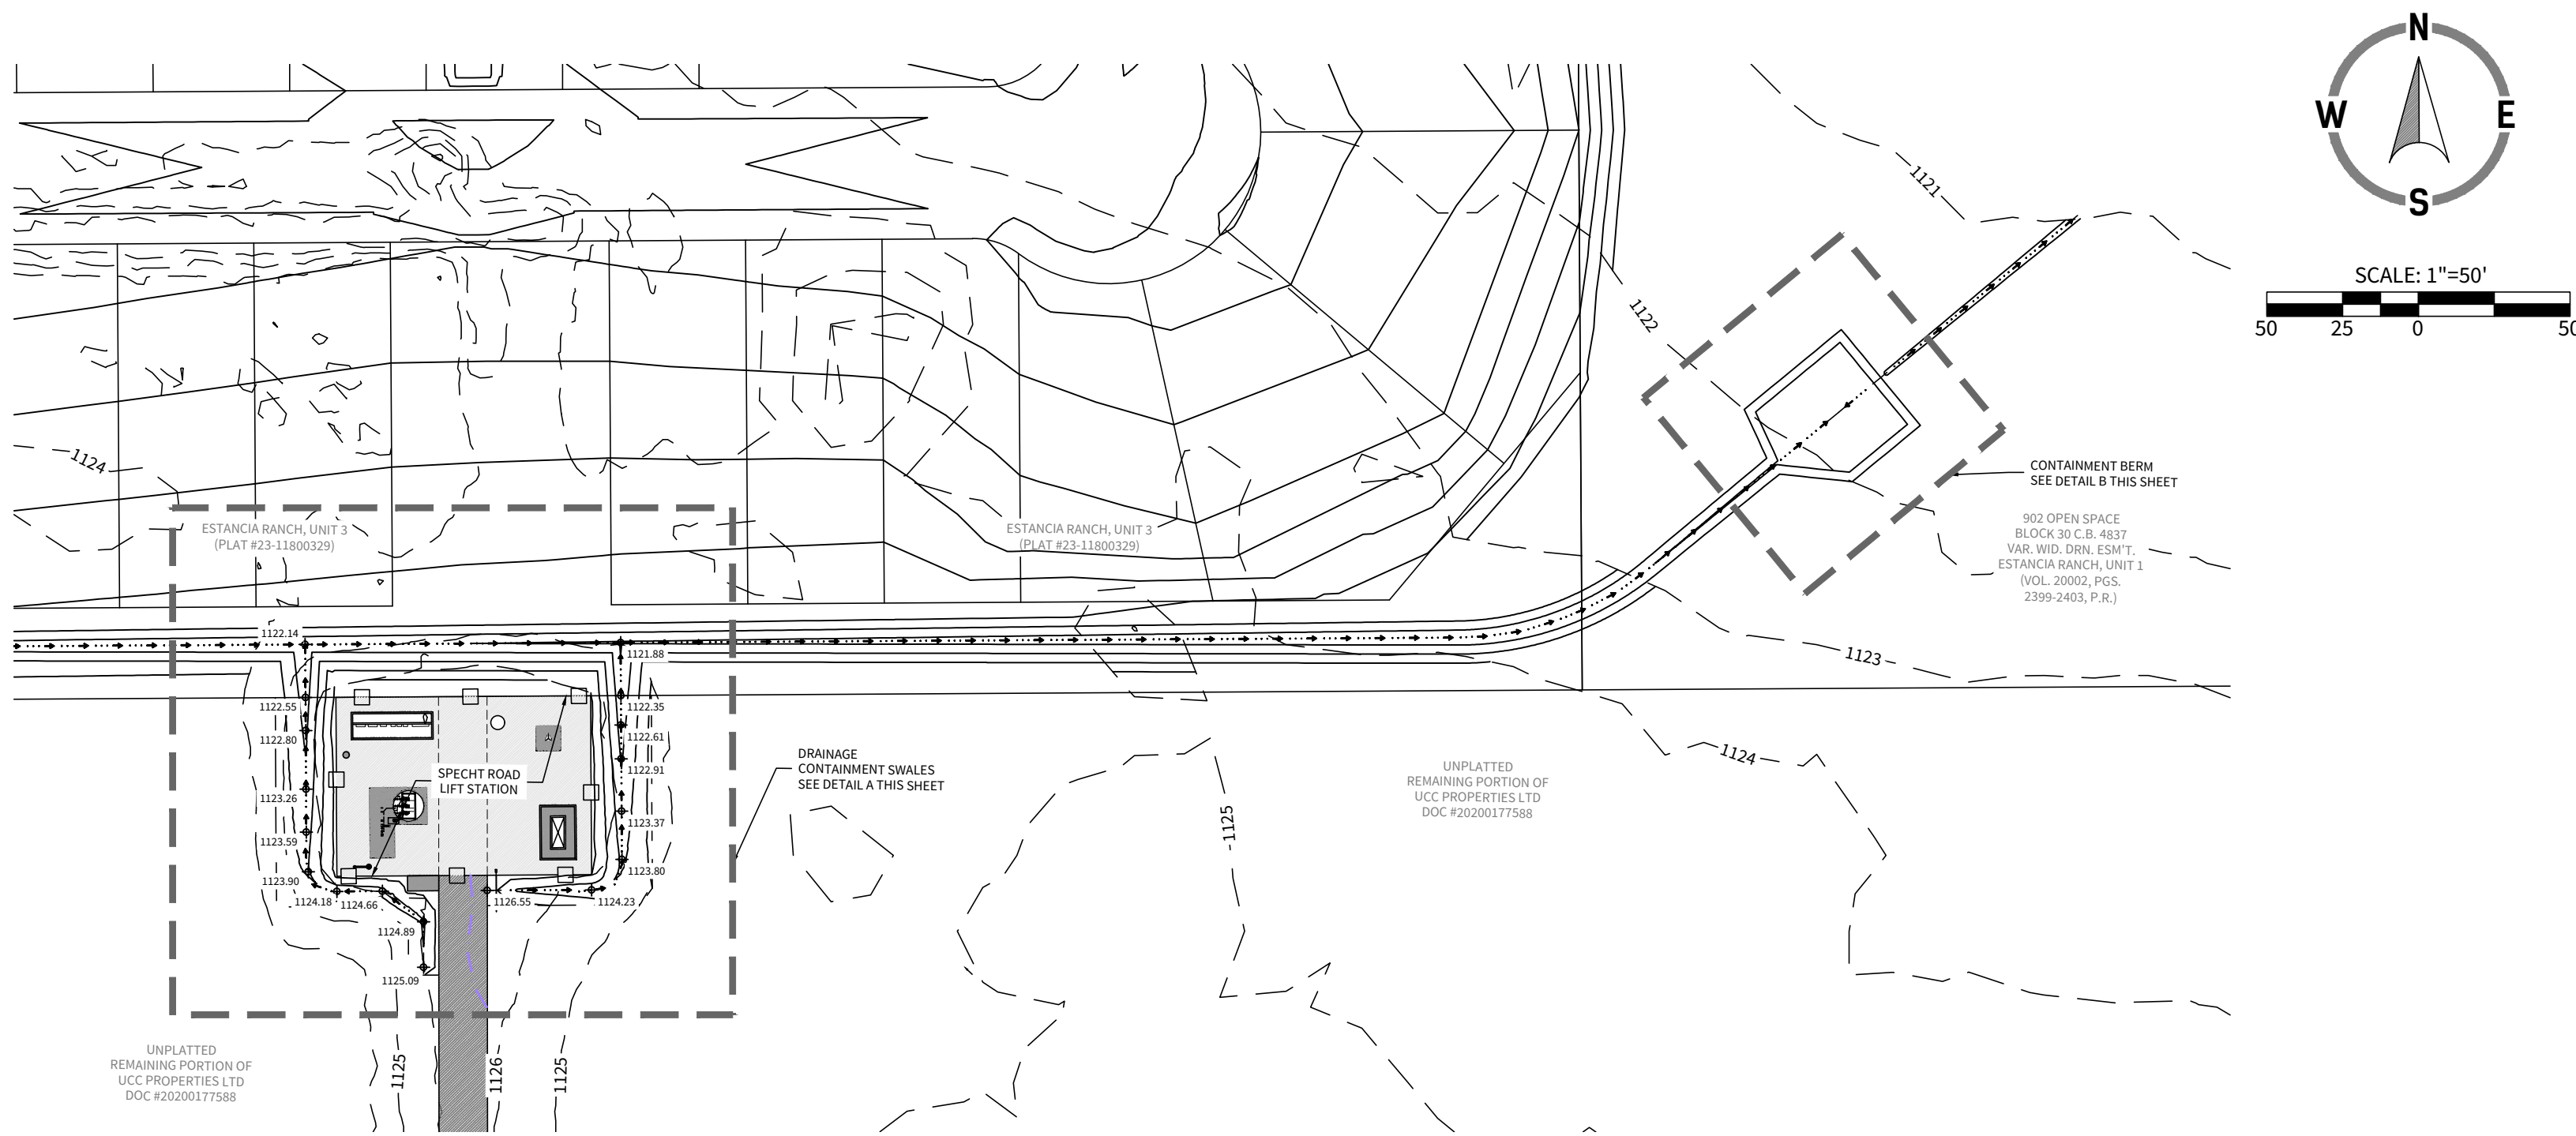

DETAIL "A"
SCALE 1" = 20'

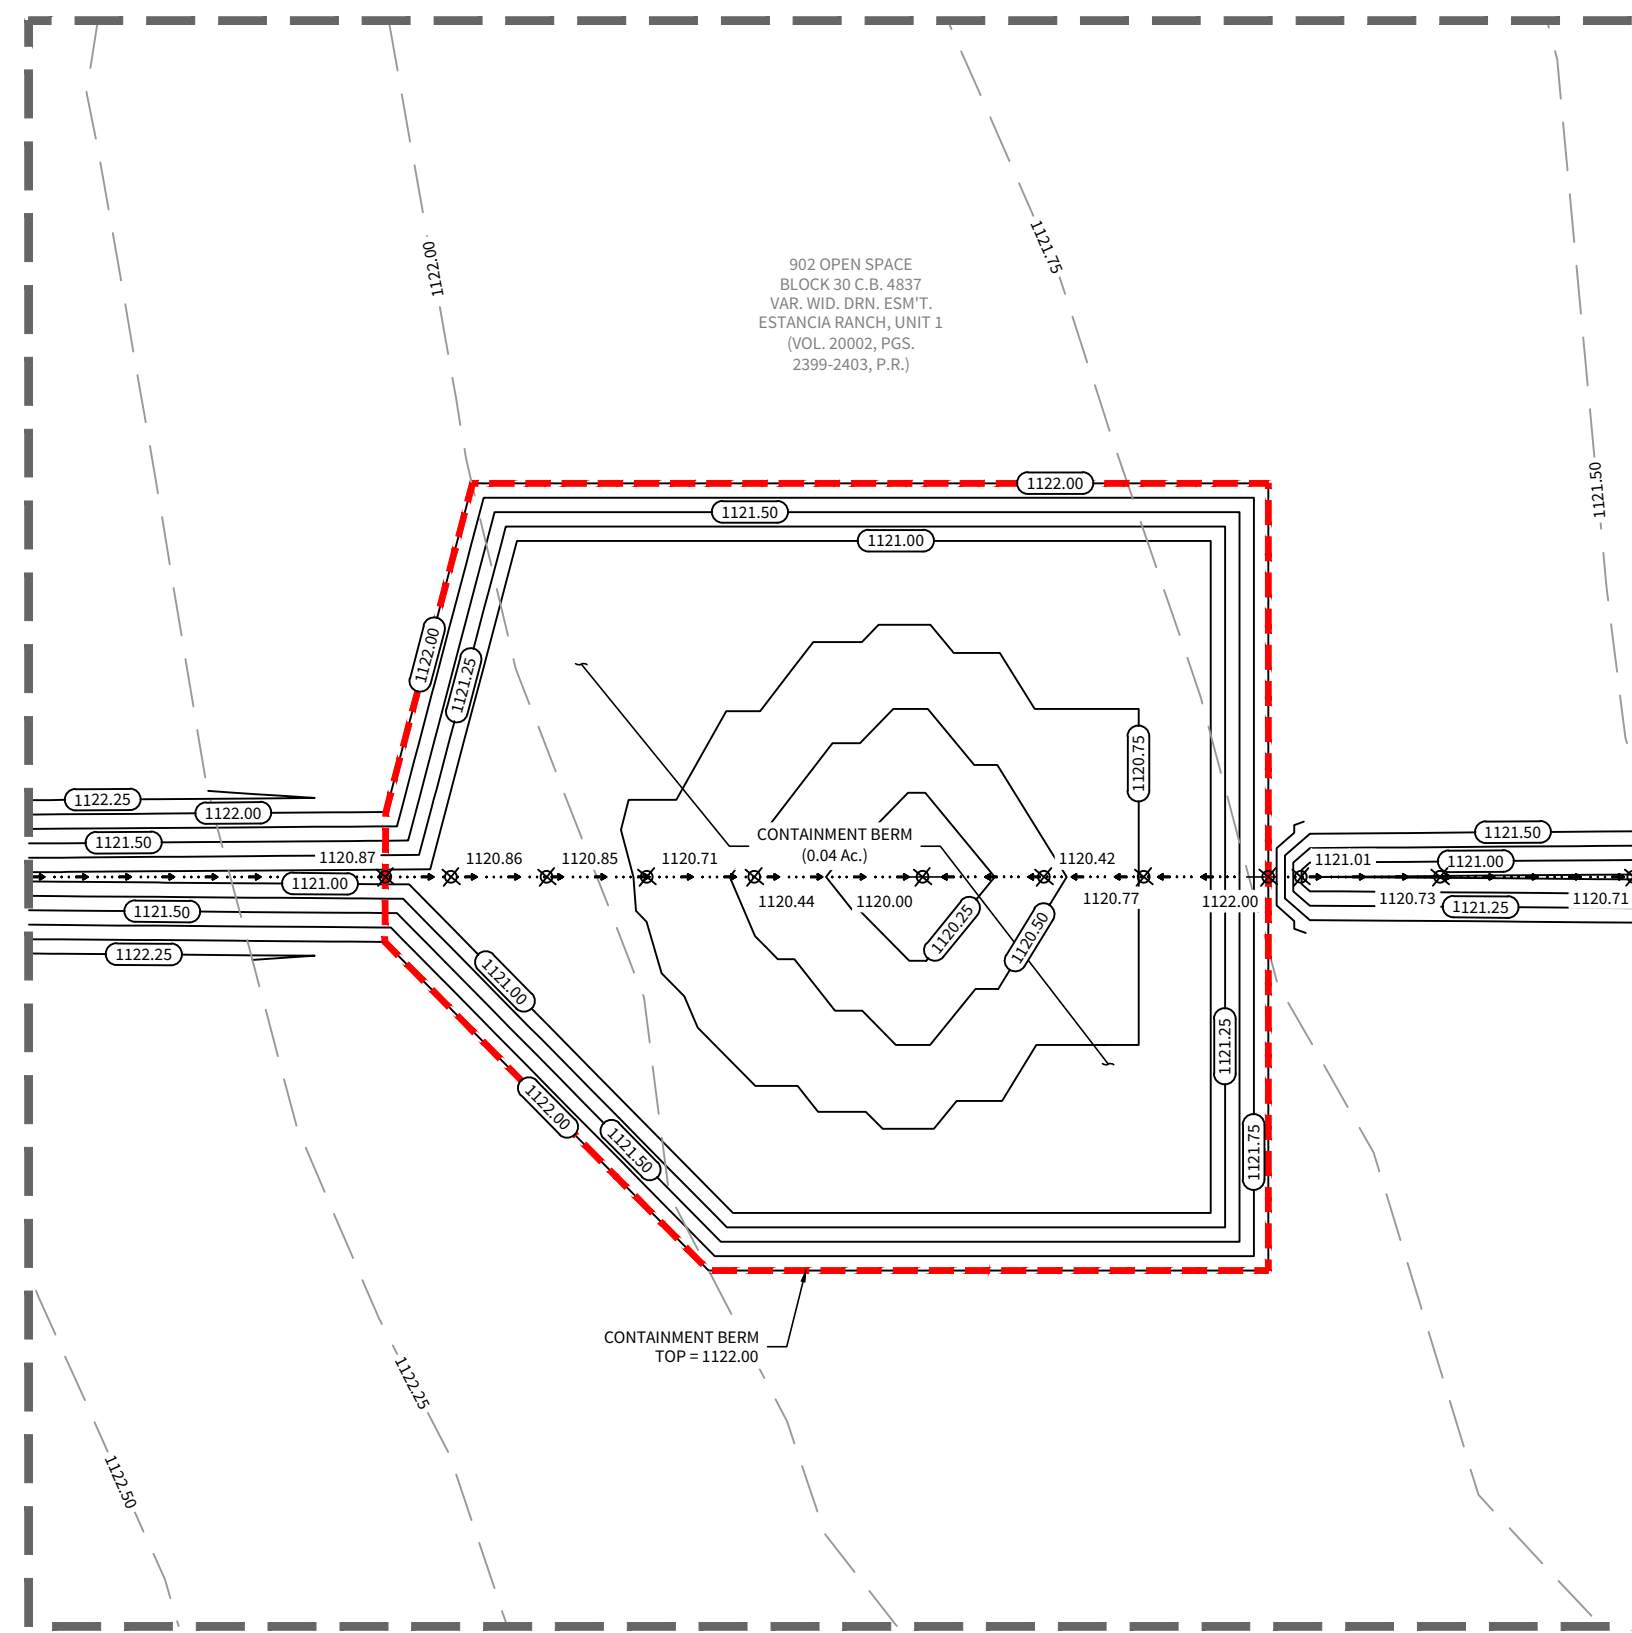

DETAIL "B"
SCALE 1" = 10'

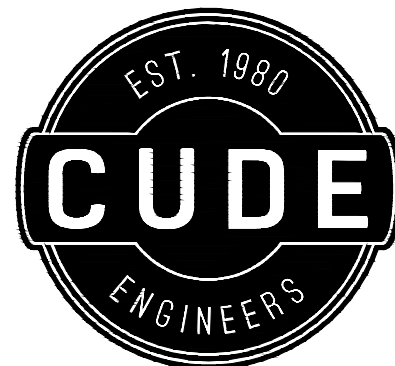

4122 Pond Hill Road, Suite 101
San Antonio, Texas 78231
P:(210) 681.2951 F:(210) 523.7112

SPECHT ROAD SUBDIVISION
OFFSITE SEWER IMPROVEMENTS
DUAL 6" FORCE MAIN & LIFT STATION

CONTAINMENT SWALE & BERM GRADING EXHIBIT

DATE

04/29/2024

PROJECT NO.
03473.002

DRAWN BY
CLM

CHECKED BY
DDC

REVISIONS

-
-
CUDE ENGINEERS
TBPE No. 455
TBPLS No. 10048500

PLAT NO.
N/A

SAWS JOB NO.
20-1595

M1.00