



www.colliersengineering.com

Copyright © 2024, Colliers Engineering & Design All Rights Reserved. This drawing and all the information contained herein is authorized for use only by the party for whom the services were contracted or to whom it is certified. This drawing may not be copied, reused, disclosed, distributed or relied upon for any other purpose without the express written consent of Colliers Engineering & Design.

Formerly Known as



811
 now what's below.
 Call before you dig.
 FOR STATE SPECIFIC DIRECT PHONE NUMBERS
 VISIT: WWW.CALL811.COM

REV	DATE	DRAWN BY	DESCRIPTION
1	1	1	
2	2	2	
3	3	3	
100	100	100	

**MORGAN'S INCLUSION
CAMPUS**

FOR

**GORDON HARTMAN
FAMILY FOUNDATION
- CAPITAL**

CITY OF NEW BRAUNFELS
COMAL COUNTY
TEXAS



Colliers
Engineering
& Design


NEW BRAUNFELS (KFW)
640 N. Walnut Ave.
Suite 1101
New Braunfels, TX 78130
Phone: 830.220.6042
COLLIERS ENGINEERING & DESIGN, INC.
TBPB Firm#: F-14909
TBPBS Firm#: 10194550

SCALE:	DATE:	DRAWN BY:	CHECKED BY:
AS SHOWN	11/01/23	MF	DA
PROJECT NUMBER:	DRAWING NAME:		
205-34-02	SILT FENCE EXHIBIT PHASE II		

SHEET TITLE:


SILT FENCE EXHIBIT

SHEET NUMBER: EX

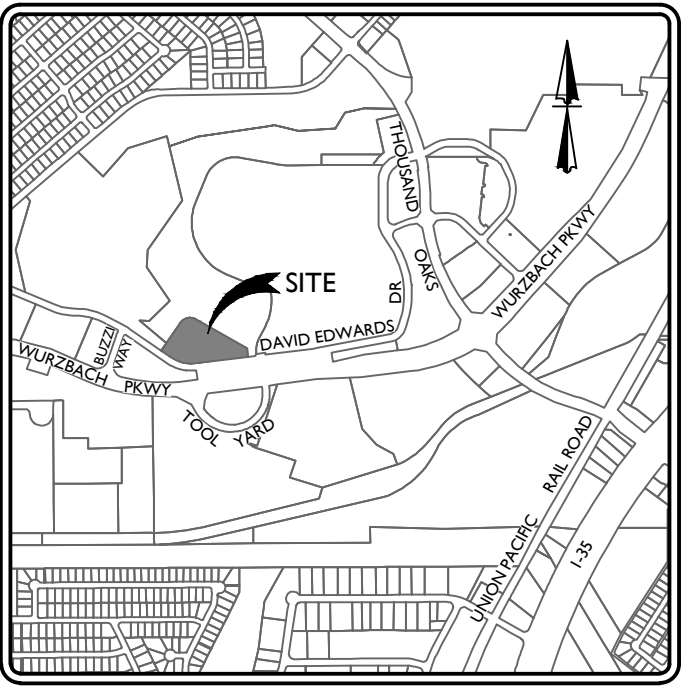


LOCATION MAP

NOT TO SCALE

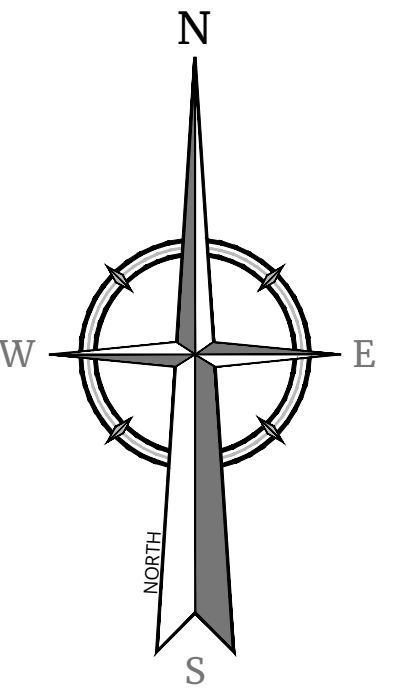

SCALE : 1" = 30'
Linear unit of measure: US Survey Foot (1 ft = 1200/3937 m)

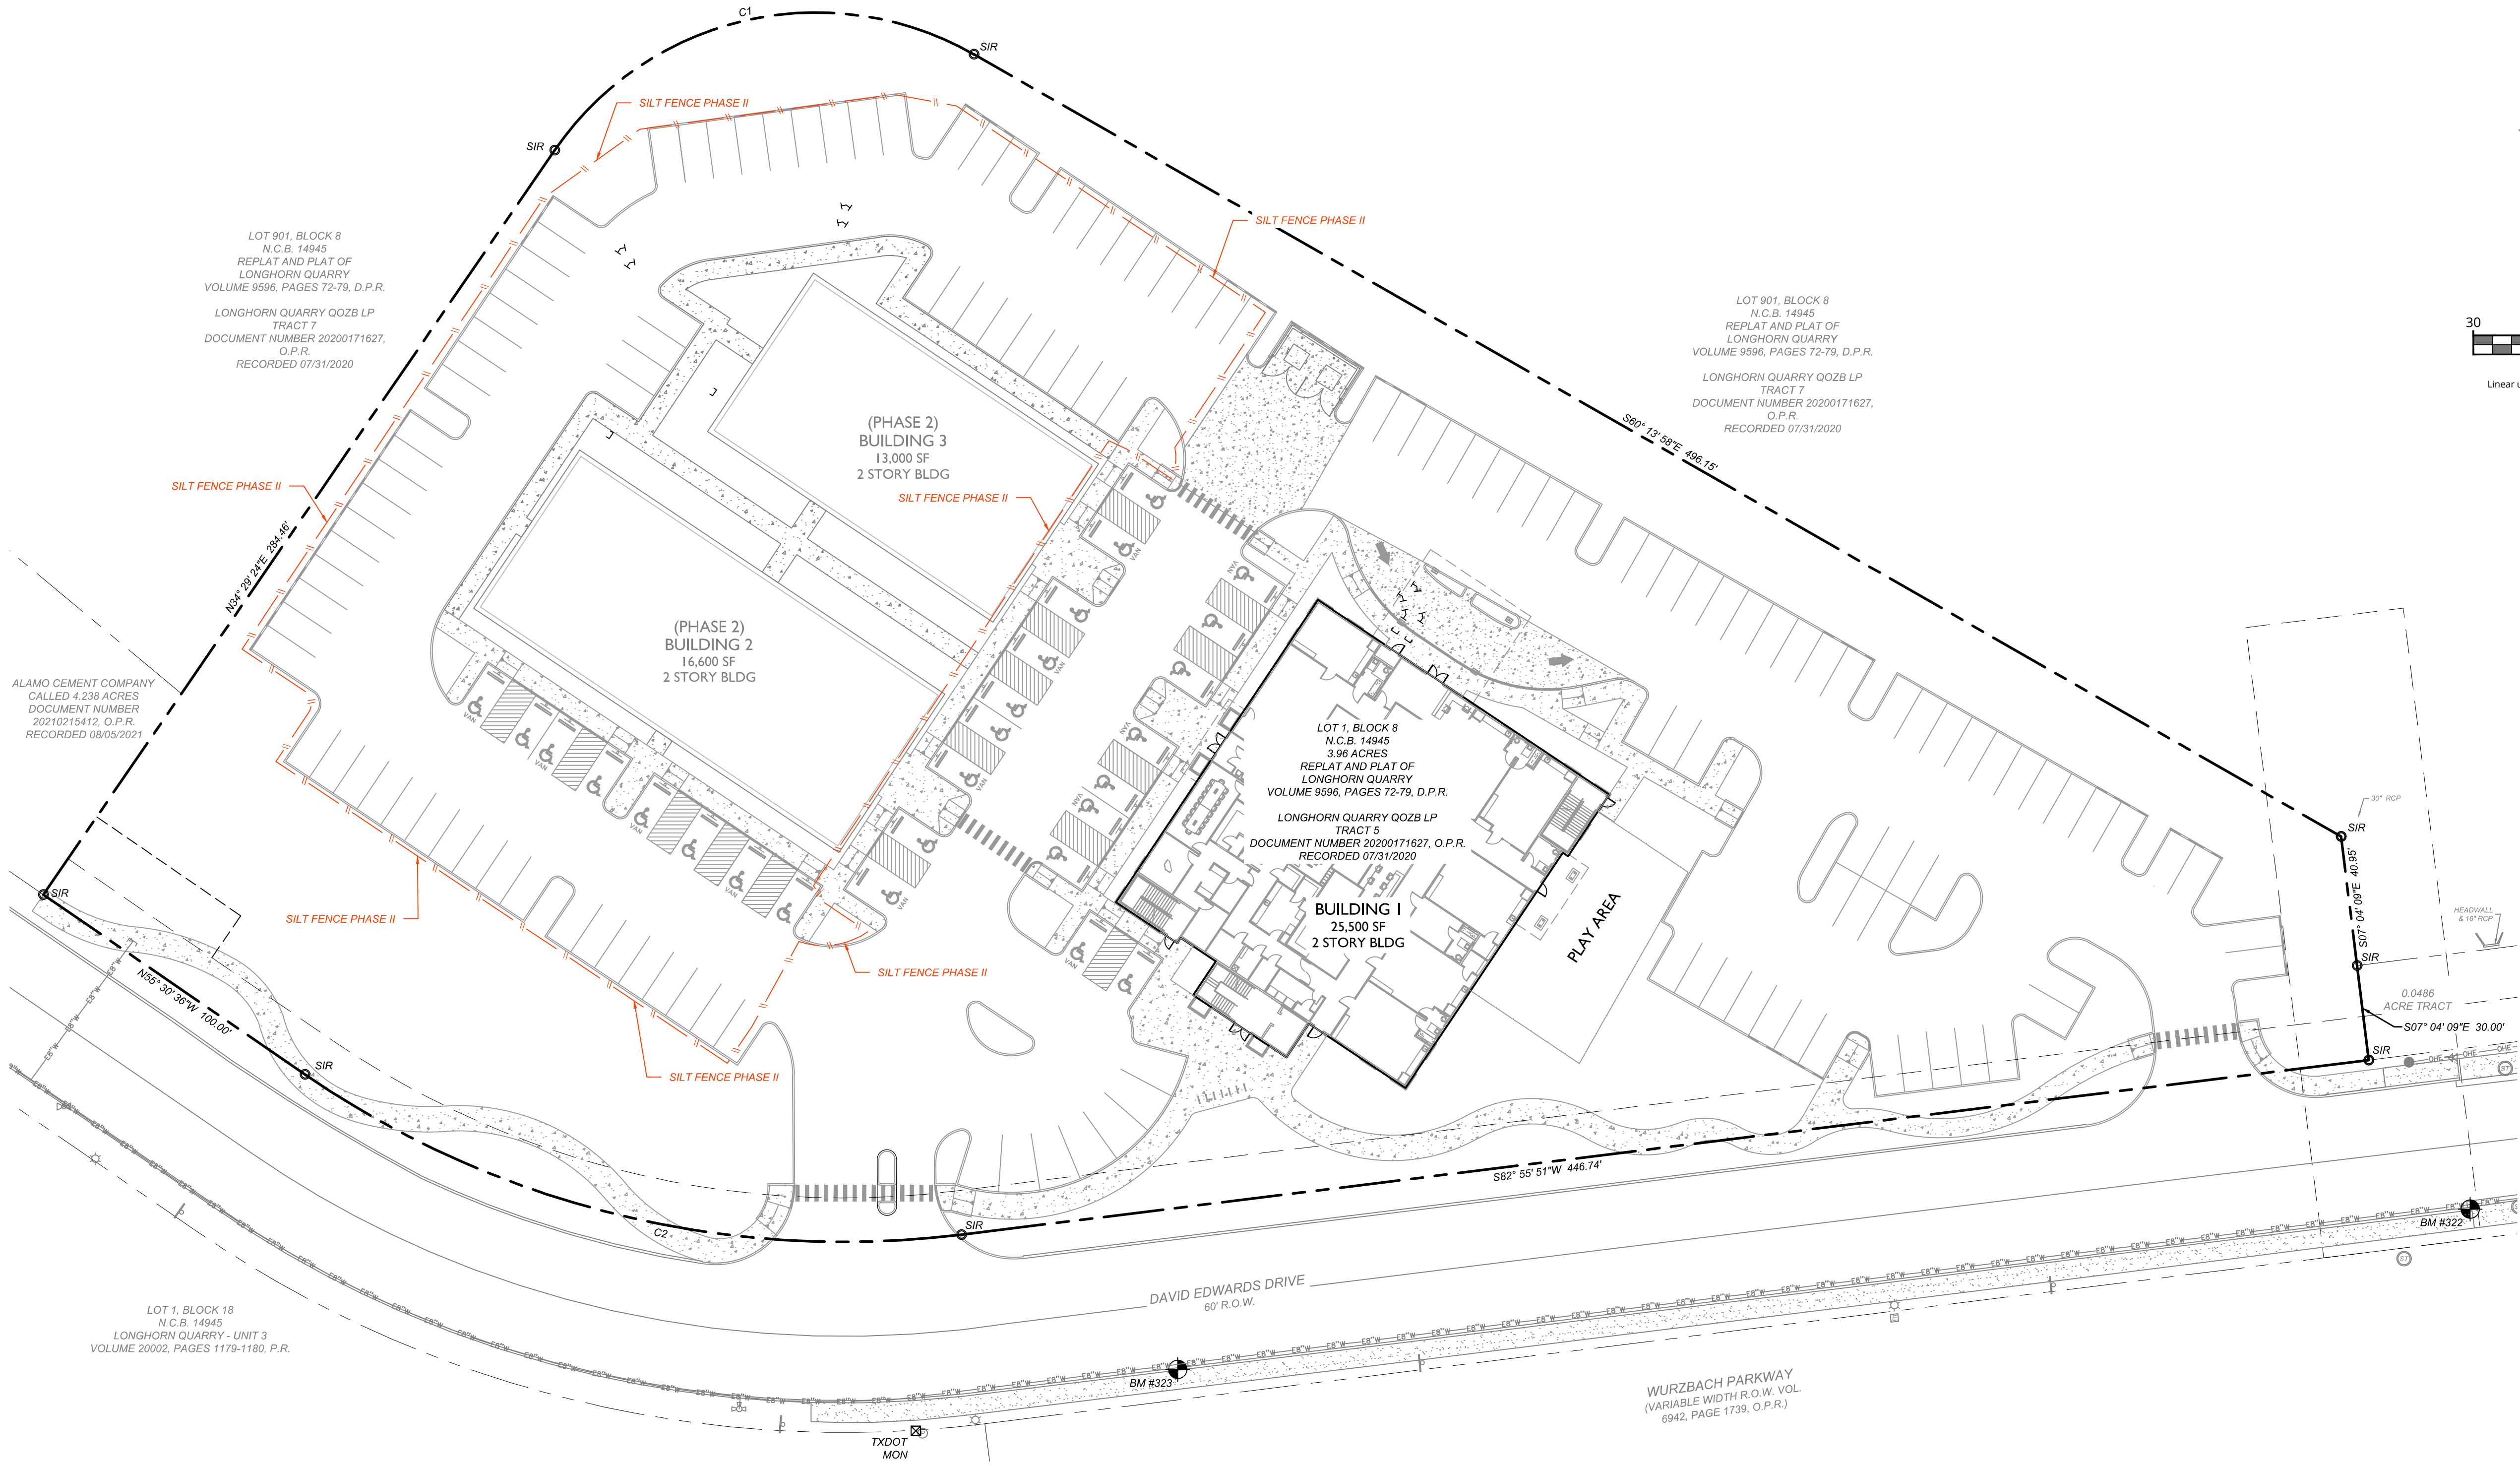

NOTE: DO NOT SCALE DRAWINGS FOR CONSTRUCTION

Date: Jan 12, 2024, 1:19pm User ID: davendano
File: U:\Projects\205\34\02\Design\Exhibits\CAD\SILT FENCE EXHIBIT PHASE II.dwg
IDesign\Exhibits\CAD\SILT FENCE EXHIBIT PHASE II.dwg\C4.0 FIRE PROTECTION PLAN By: DAVENDANO